

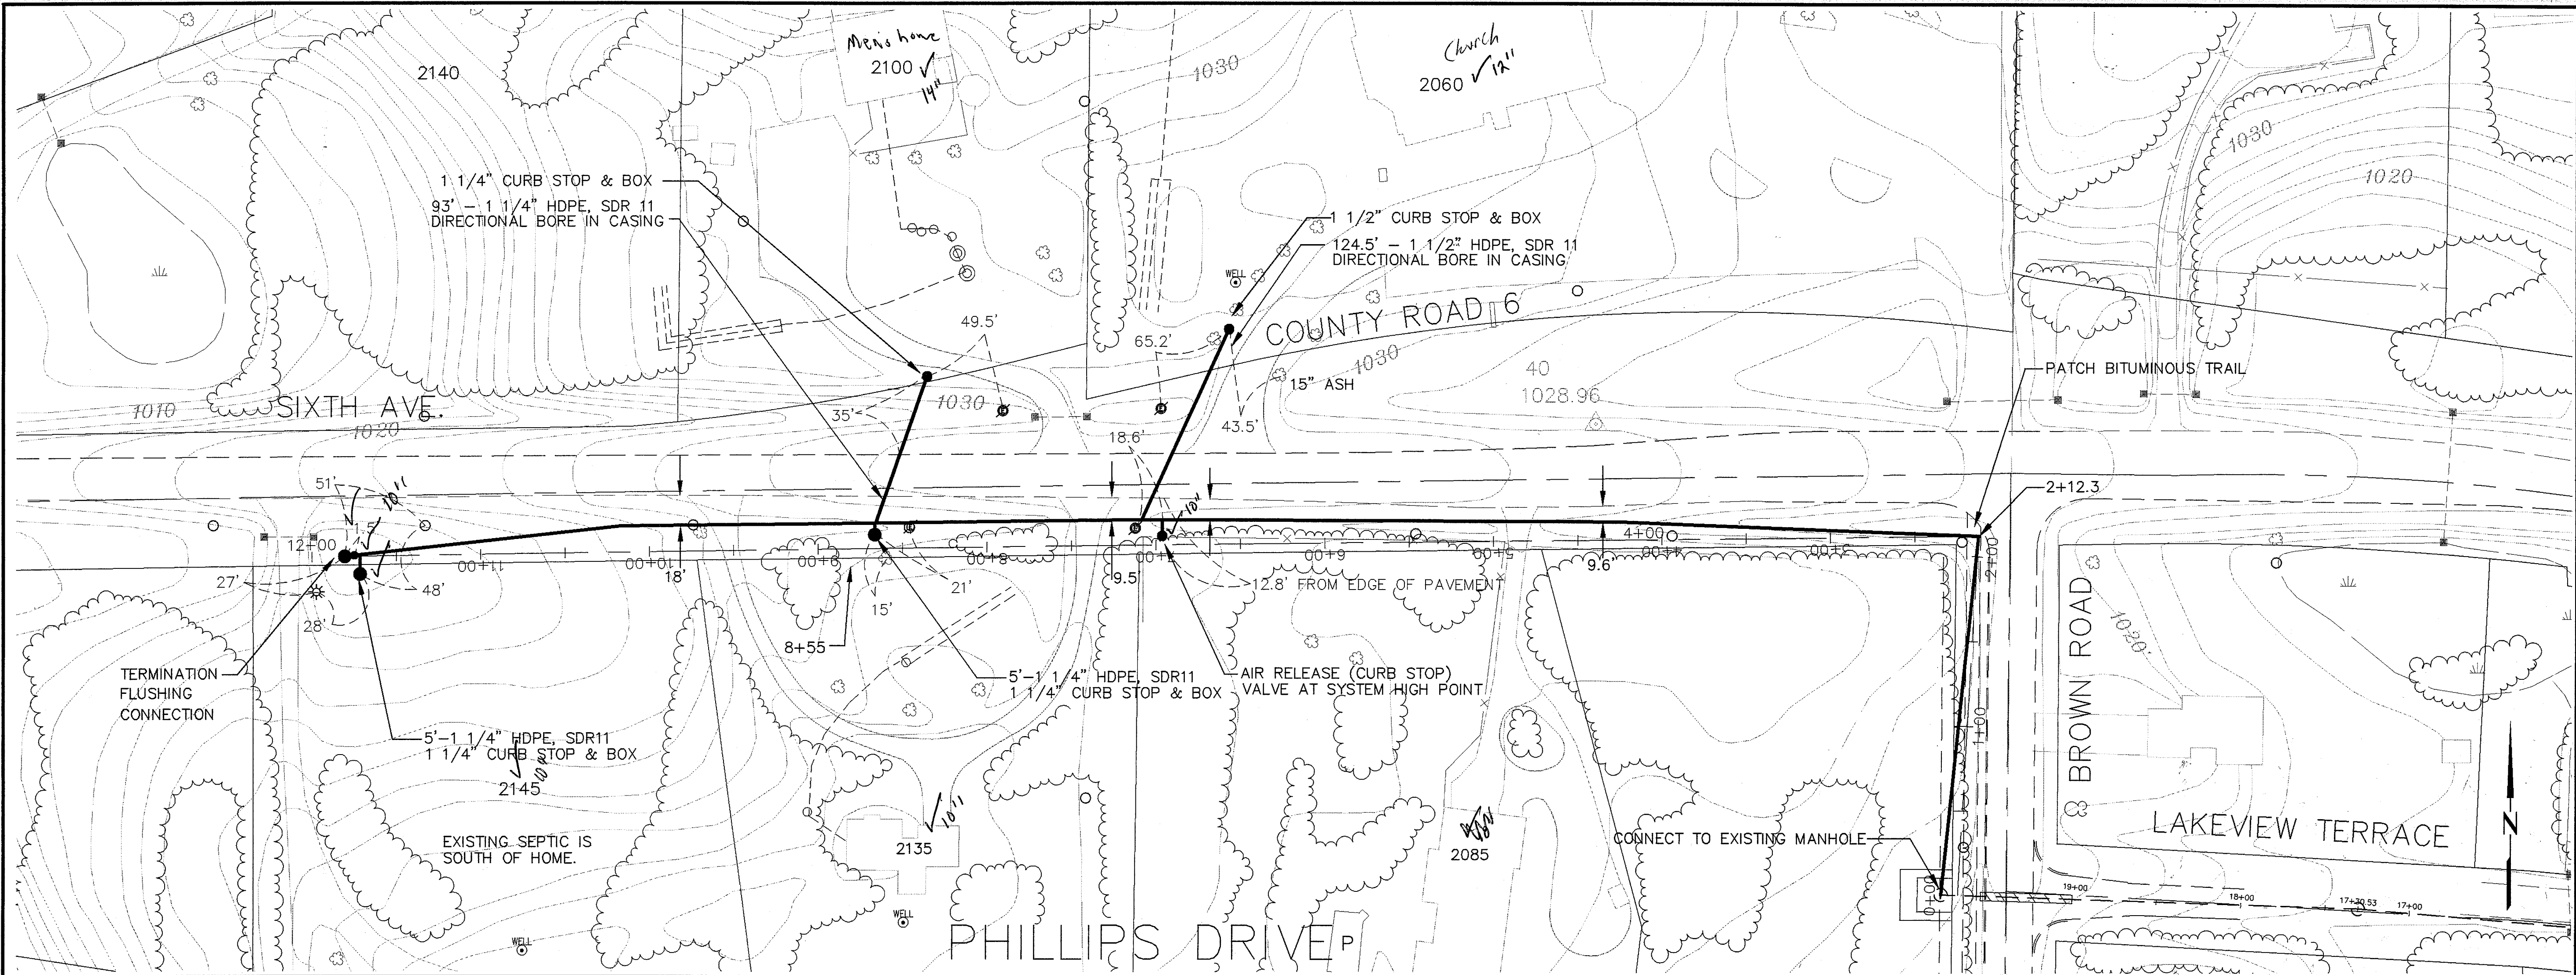


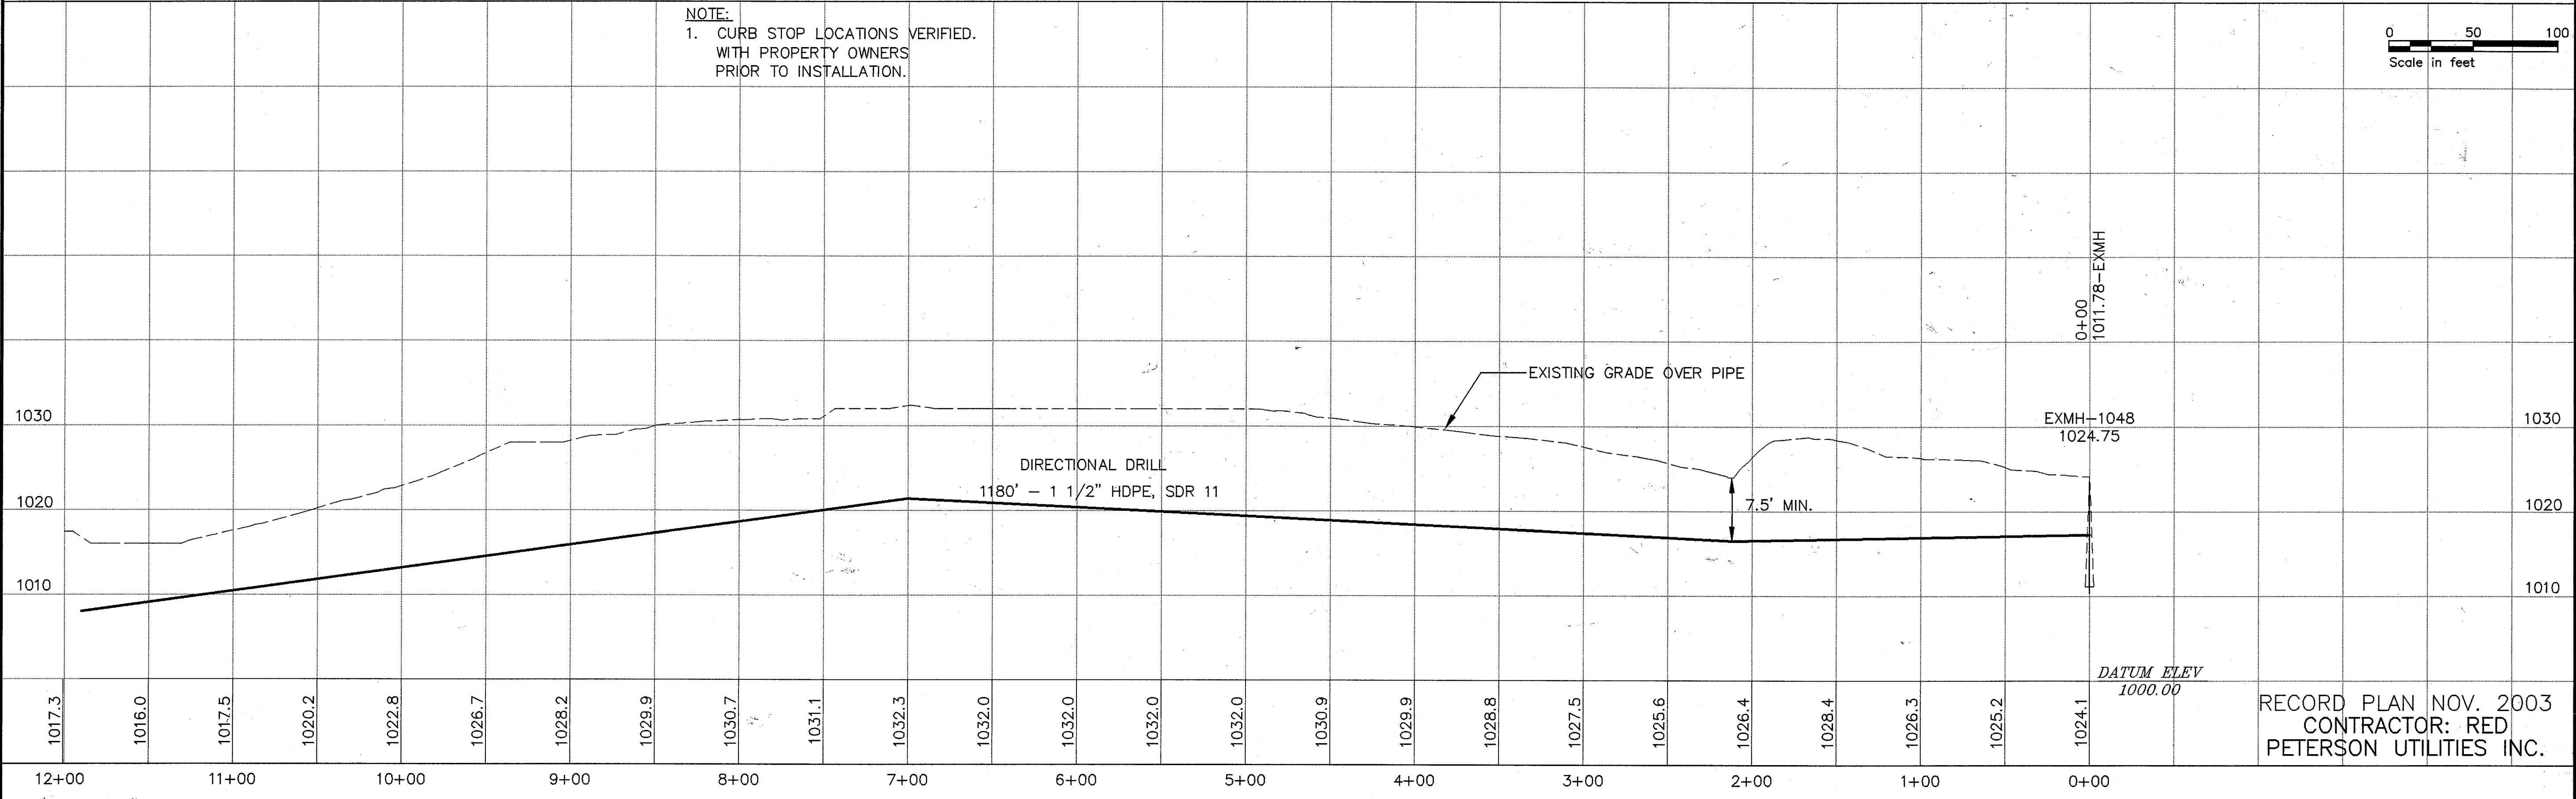

NOTE:
1. CURB STOP LOCATIONS VERIFIED.
WITH PROPERTY OWNERS
PRIOR TO INSTALLATION.

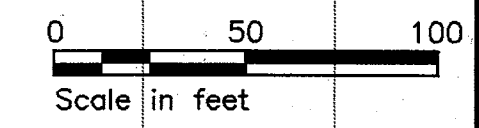

RECORD PLAN NOV. 2003
CONTRACTOR: RED
PETERSON UTILITIES INC.

I HEREBY CERTIFY THAT THIS PLAN, SPECIFICATION, OR REPORT WAS PREPARED BY ME OR UNDER MY CLOSE PERSONAL SUPERVISION AND THAT I AM A FULLY LICENSED PROFESSIONAL ENGINEER UNDER THE LAWS OF THE STATE OF MINNESOTA. PRINT NAME: Thomas P. Kellogg		SURVEY DRAWN DESIGNED APPROVED DATE PROJ. NO.
SIGNATURE: <i>Thomas P. Kellogg</i> DATE: August 18, 2003 LIC. NO.: 26917		9/18/03 13603140
St. Paul Office 2335 West Highway 36 St. Paul, MN 55113 Phone: 651-636-4600 Fax: 651-636-1311		
Bonestroo Roserne Anderlik & Associates Engineers & Architects www.bonestroo.com		
ORONO, MINNESOTA PHILLIPS SANITARY SEWER EXTENSION SANITARY SEWER PLAN AND PROFILE		
13903140C4.01.DWG SHEET NUMBER C4.01		